



System Under Test:

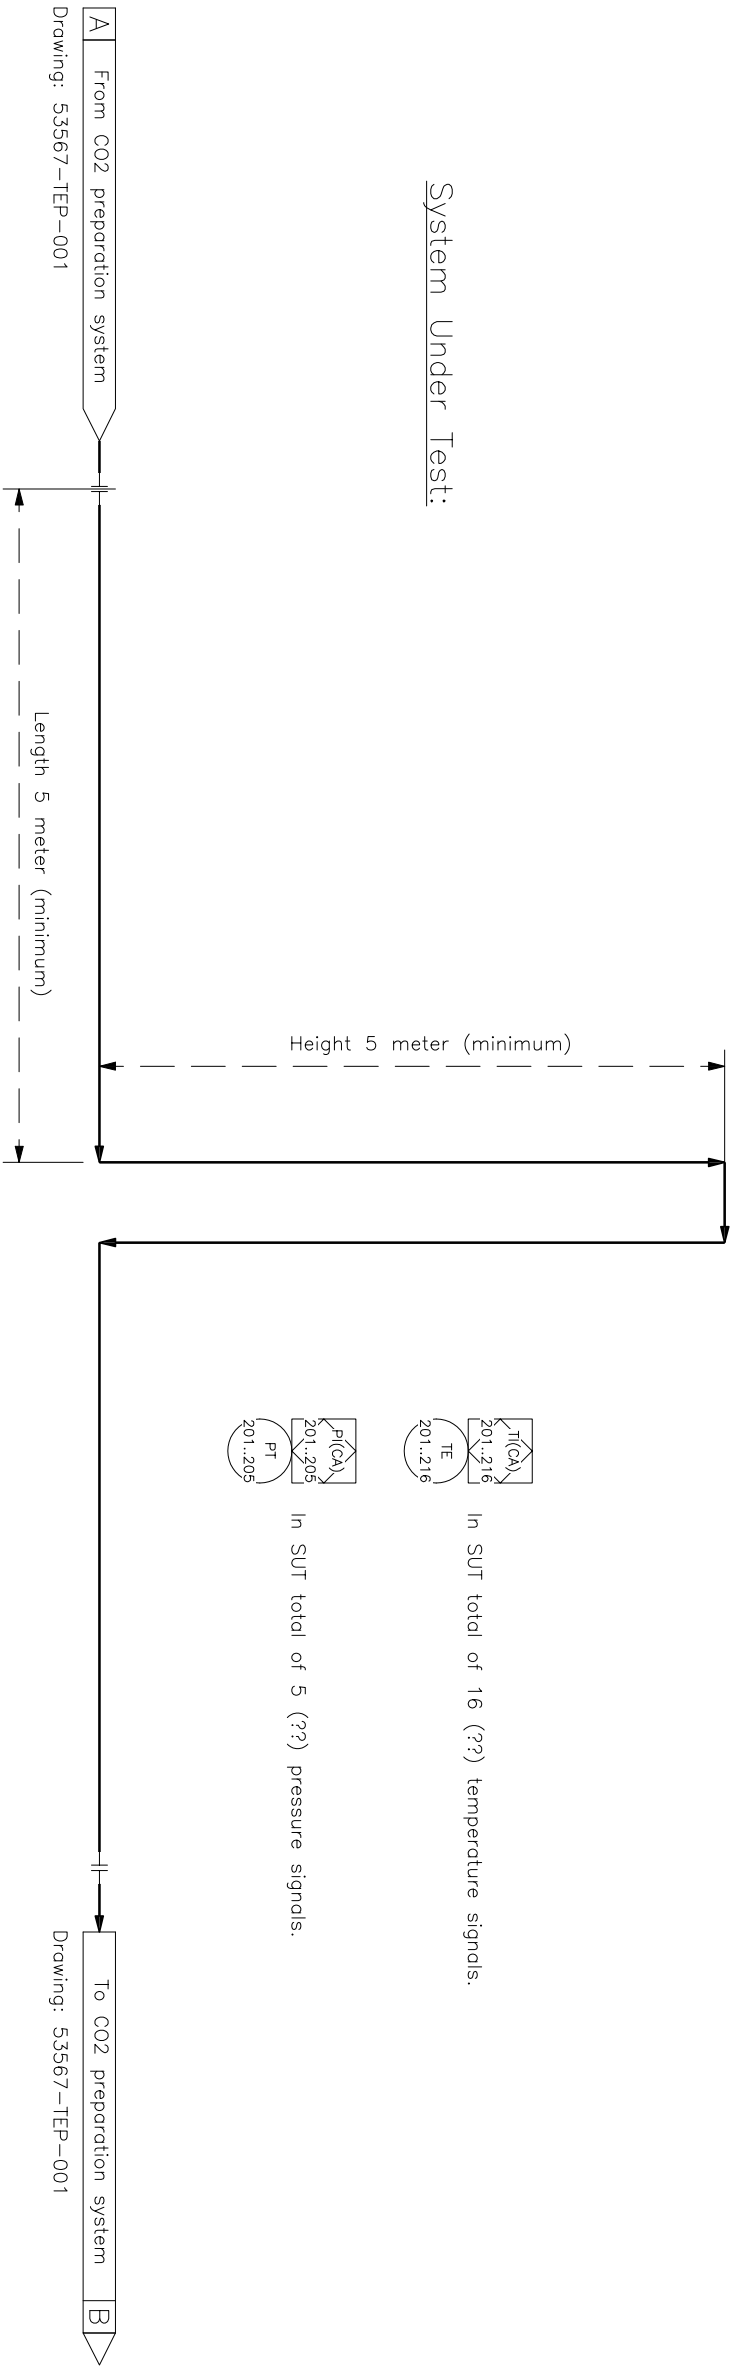

Gas Filling Station:

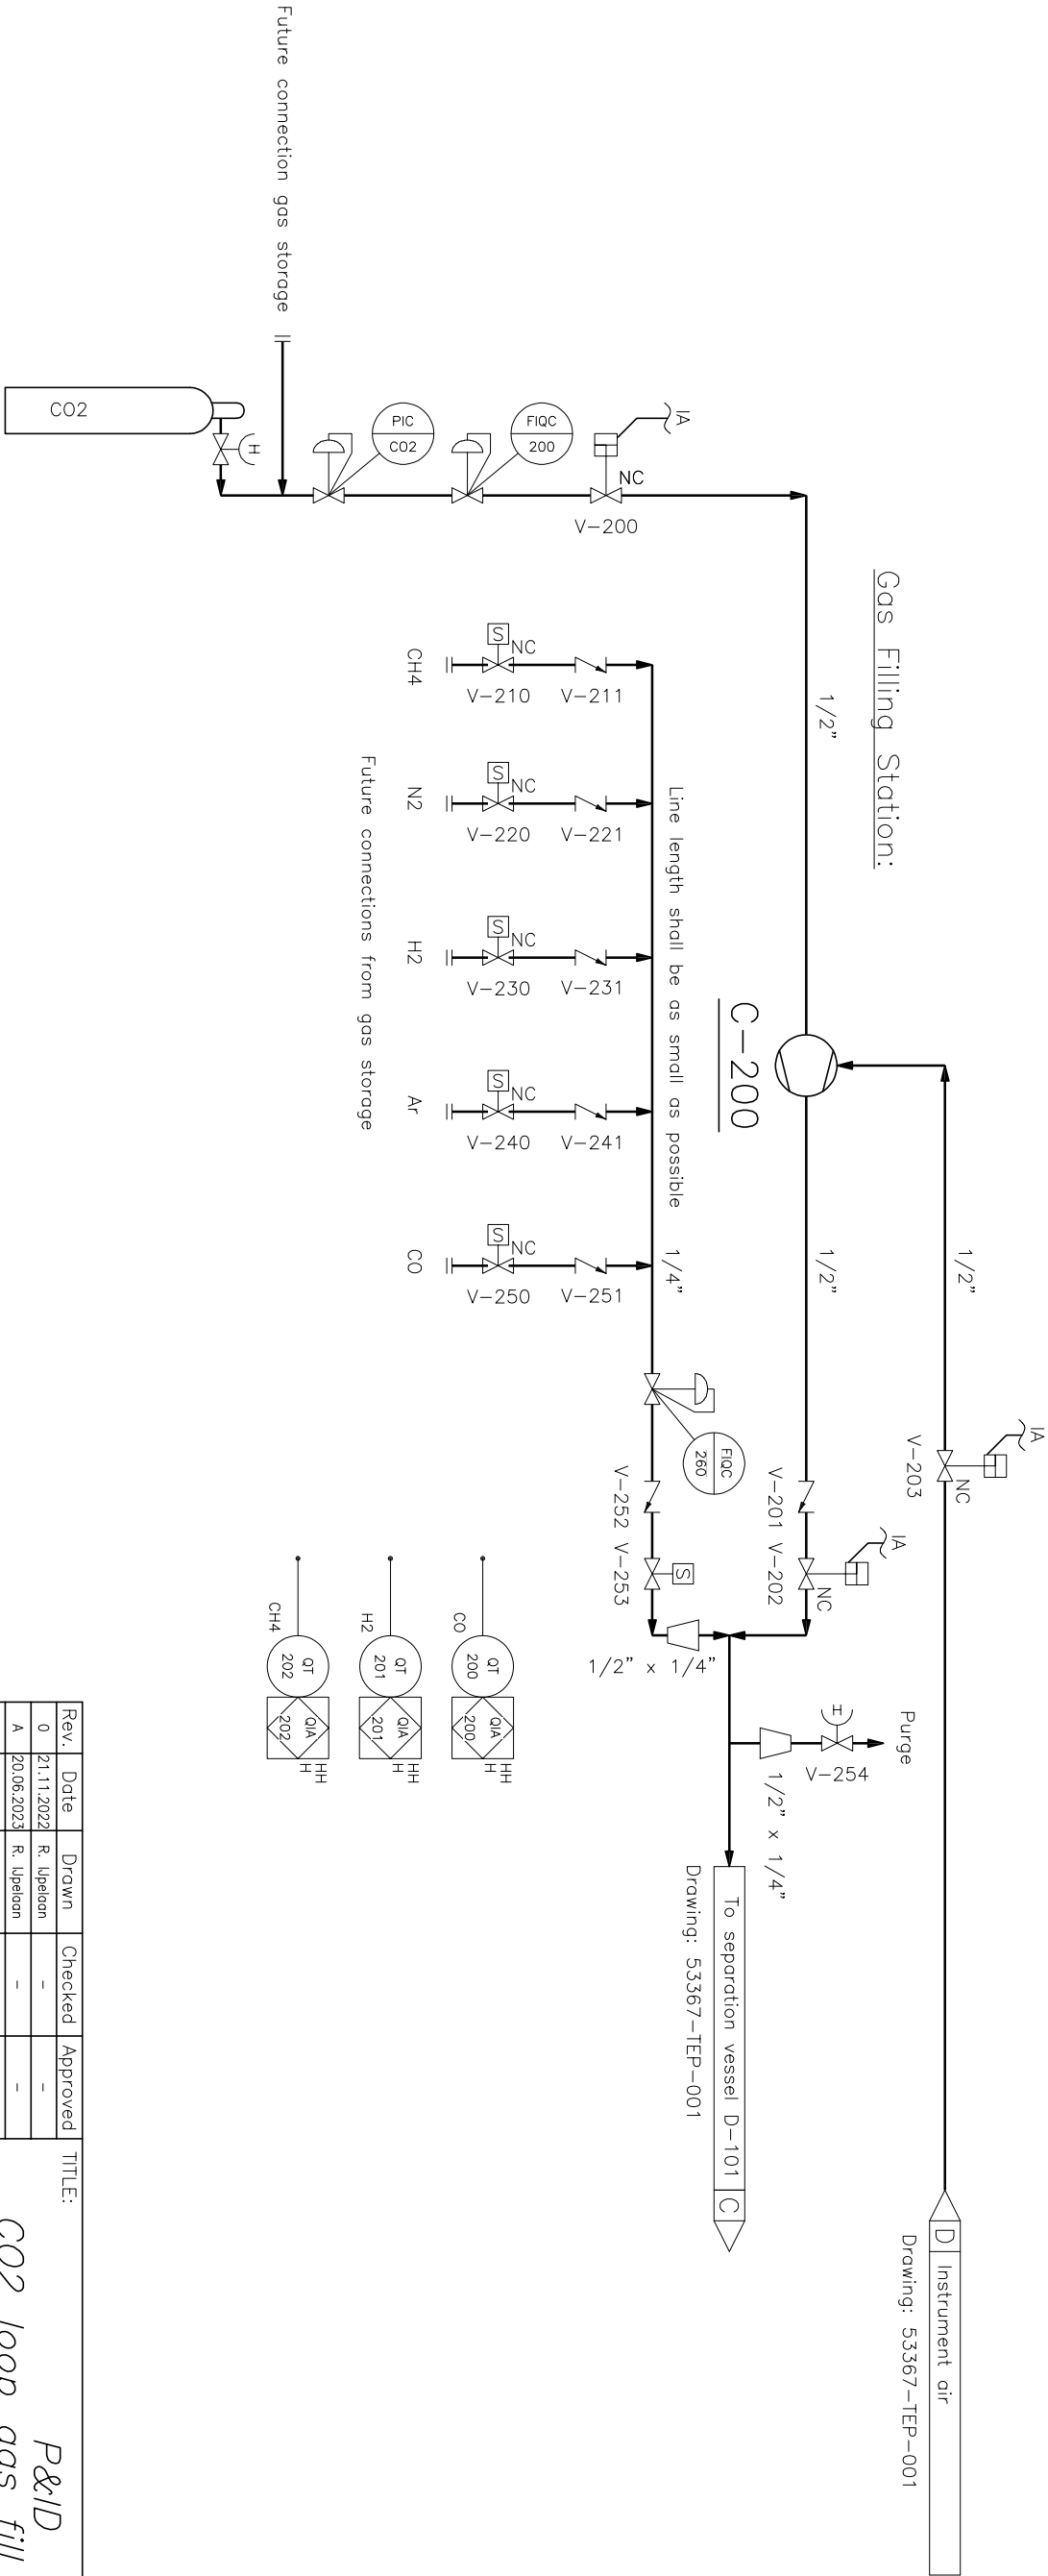

Rev.	Date	Drawn	Checked	Approved	TITLE:				
0	21.11.2022	R. Ulpelcan	-	-	P&ID CO2 loop gas fill and SUT				
A	20.06.2023	R. Ulpelcan	-	-					
B	04.08.2023	R. Ulpelcan	-	-					
					SUBJECT:		DWG.NR.:		
					CO2 FLOW LOOP		53367-TEP-002		
COPYRIGHT BY LAW					TNO - Energy Transition			PROJECT NR.: 060.53367	DWG.SIZE: A2