


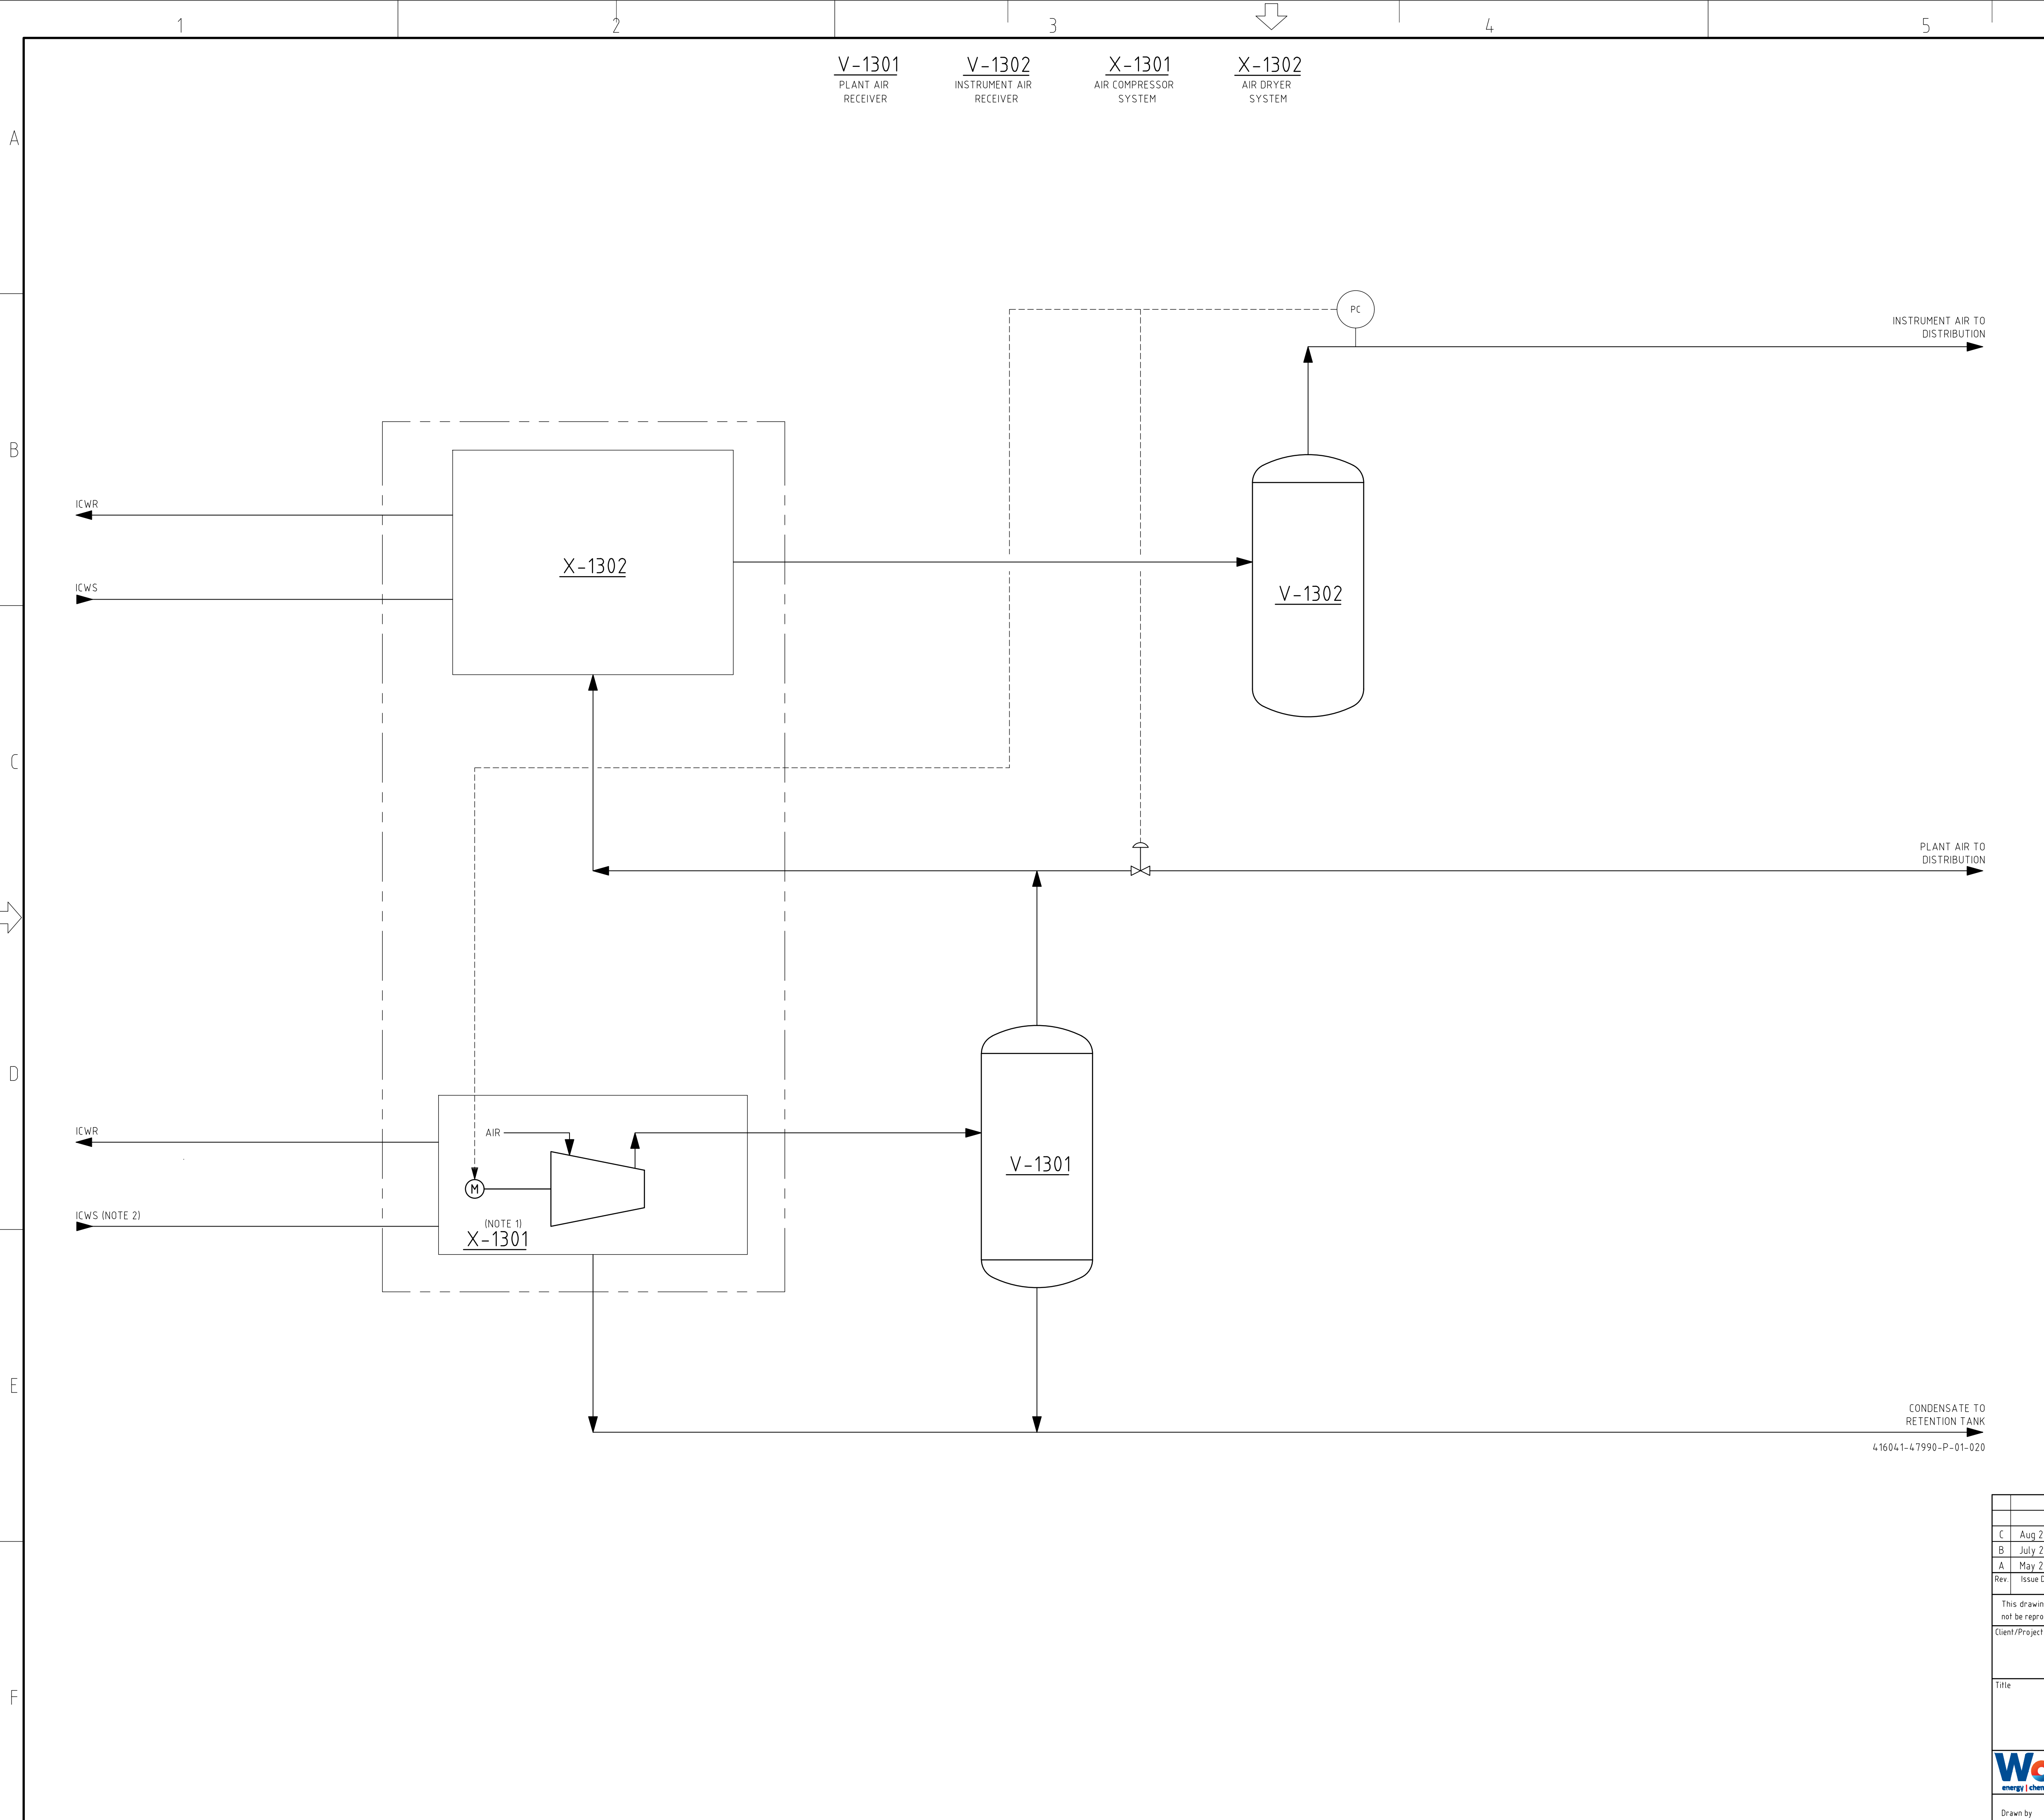

NOTES

1. COMPRESSOR INTER AND AFTER COOLERS ARE NOT SHOWN IN PFD. THESE ARE INCLUDED IN AIR COMPRESSOR SYSTEM X-1301.
2. VENDOR/CONTRACTOR TO ADVISE COOLING WATER STRATEGY.

ABBREVIATIONS

ICWR = INTERNAL COOLING WATER RETURN
ICWS = INTERNAL COOLING WATER SUPPLY

C	Aug 2023	Final							
B	July 2023	For Client Review			SAR	BLGJ	THAX	JOC	
A	May 2023	For Client Review			SAR	BLGJ	THAX	JOC	
Rev	Issue Date	Revision Description			Prepared by	Checked by	Disc Appr by	Proj Appr by	
This drawing is the property of Worley and/or Client and it is loaned with the restriction that the borrower undertakes that it shall not be reproduced, copied, loaned or otherwise disposed of (directly or indirectly) nor used for any purpose other than for which it is specifically provided.									
Client/Project Name									
AEB AMSTERDAM, NL									
PROCESS FLOW DIAGRAM INSTRUMENT AIR/PLANT AIR									
Title									
Drawing Number 41604-1-47990-P-01-019									
									
Drawing by	SAR	Date	Aug 2023	Drawing Scale	NTS	Drawing Size	A1	Sheet	1 of 1
								Issue	C