


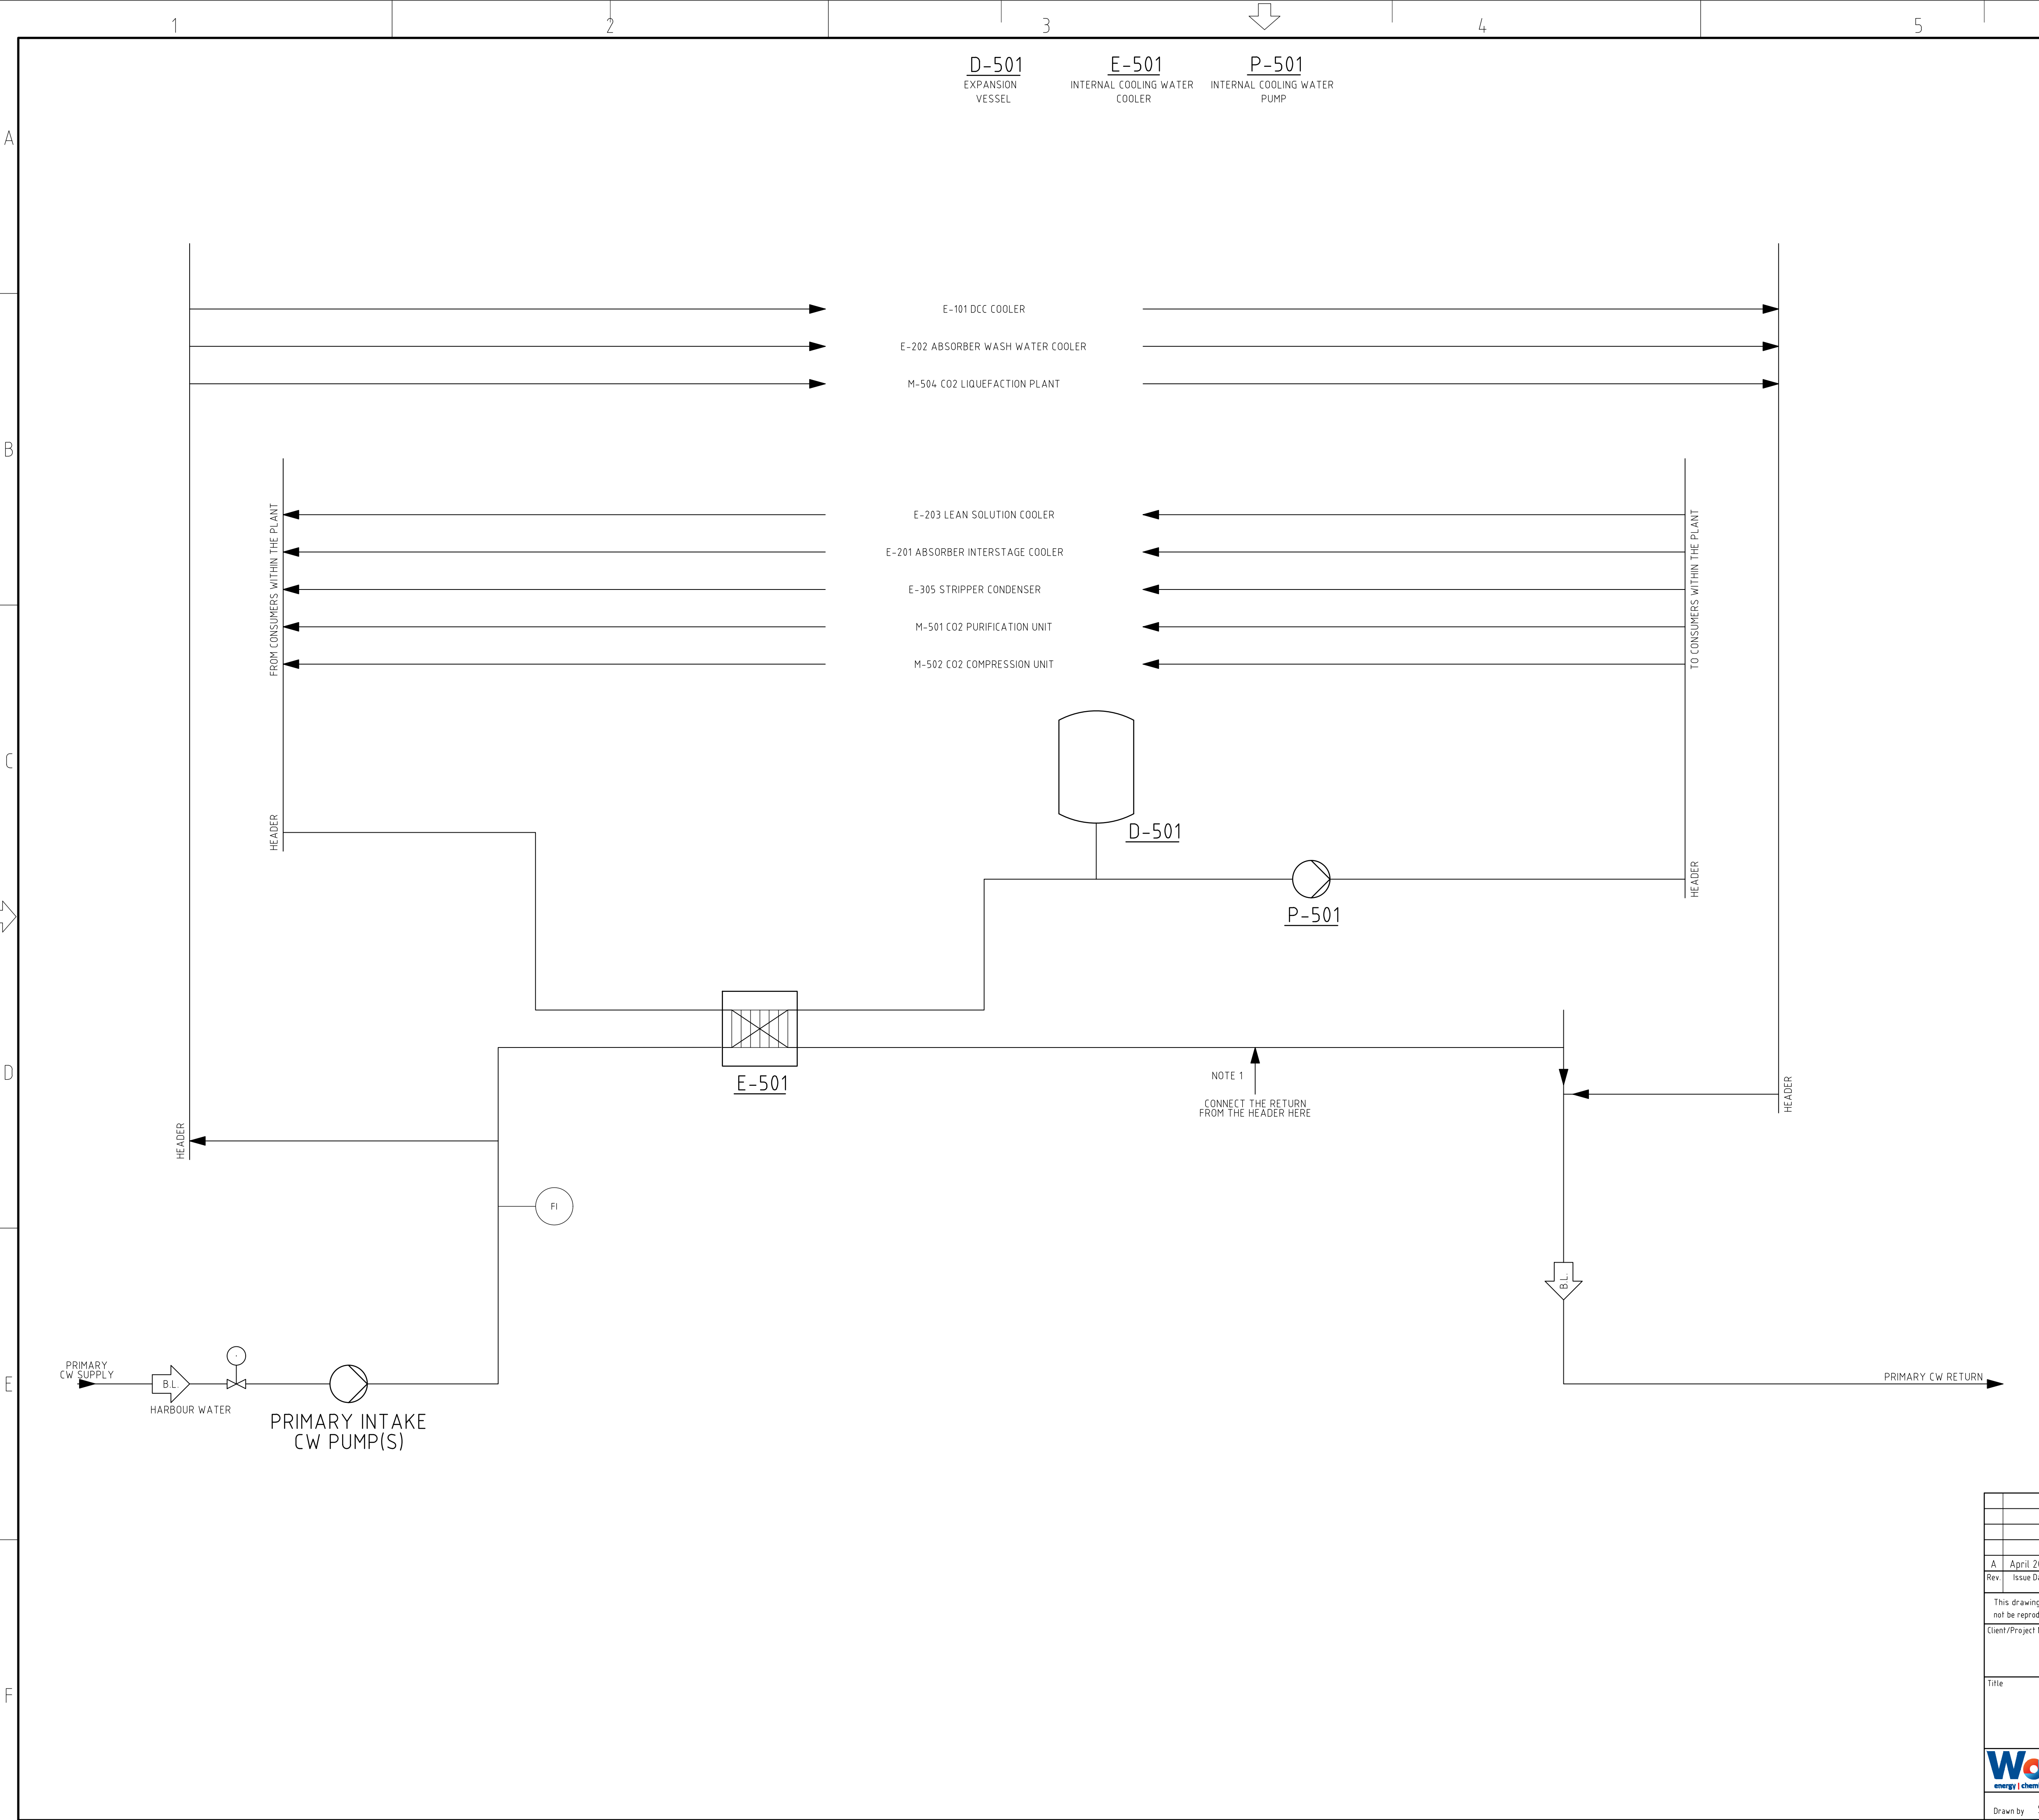

NOTES			
1. POSSIBLE TIE-IN POINT FOR TREATED PROCESS CONDENSATE.			
REMARKS			
ABBREVIATIONS			
AEC = AFVAL ENERGIE CENTRALE B.L. = BATTERY LIMIT CW = COOLING WATER DCC = DIRECT CONTACT COOLER HRC = HOOG RENDEMENT CENTRALE PCC = POST-COMBUSTION CAPTURE			

A	April 2023	For Client Review				SAR	BLGJ	THAX	JOC
Rev.	Issue Date	Revision Description				Prepared by	Checked by	Disc Appr by	Proj Appr by
This drawing is the property of Worley and/or Client and it is loaned with the restriction that the borrower undertakes that it shall not be reproduced, copied, loaned or otherwise disposed of (directly or indirectly) nor used for any purpose other than for which it is specifically provided.									
Client/Project Name									
AEB AMSTERDAM, NL									
Title									
PROCESS FLOW DIAGRAM COOLING WATER SUPPLY & RETURN									
						Drawing Number 416041-47990-P-01-013			
Drawn by SAR		Date April 2023		Drawing Scale NTS		Drawing Size A1		Sheet 1 of 1	
								Issue A	

Last saved as: C:\Users\Ray Saucedo\OneDrive - Worley\Documents (AEB)-416041-47990-P-01-013.dwg Date: 2023-04-26 11:41 Version: AutoCAD 23.1s User: Ray Saucedo