


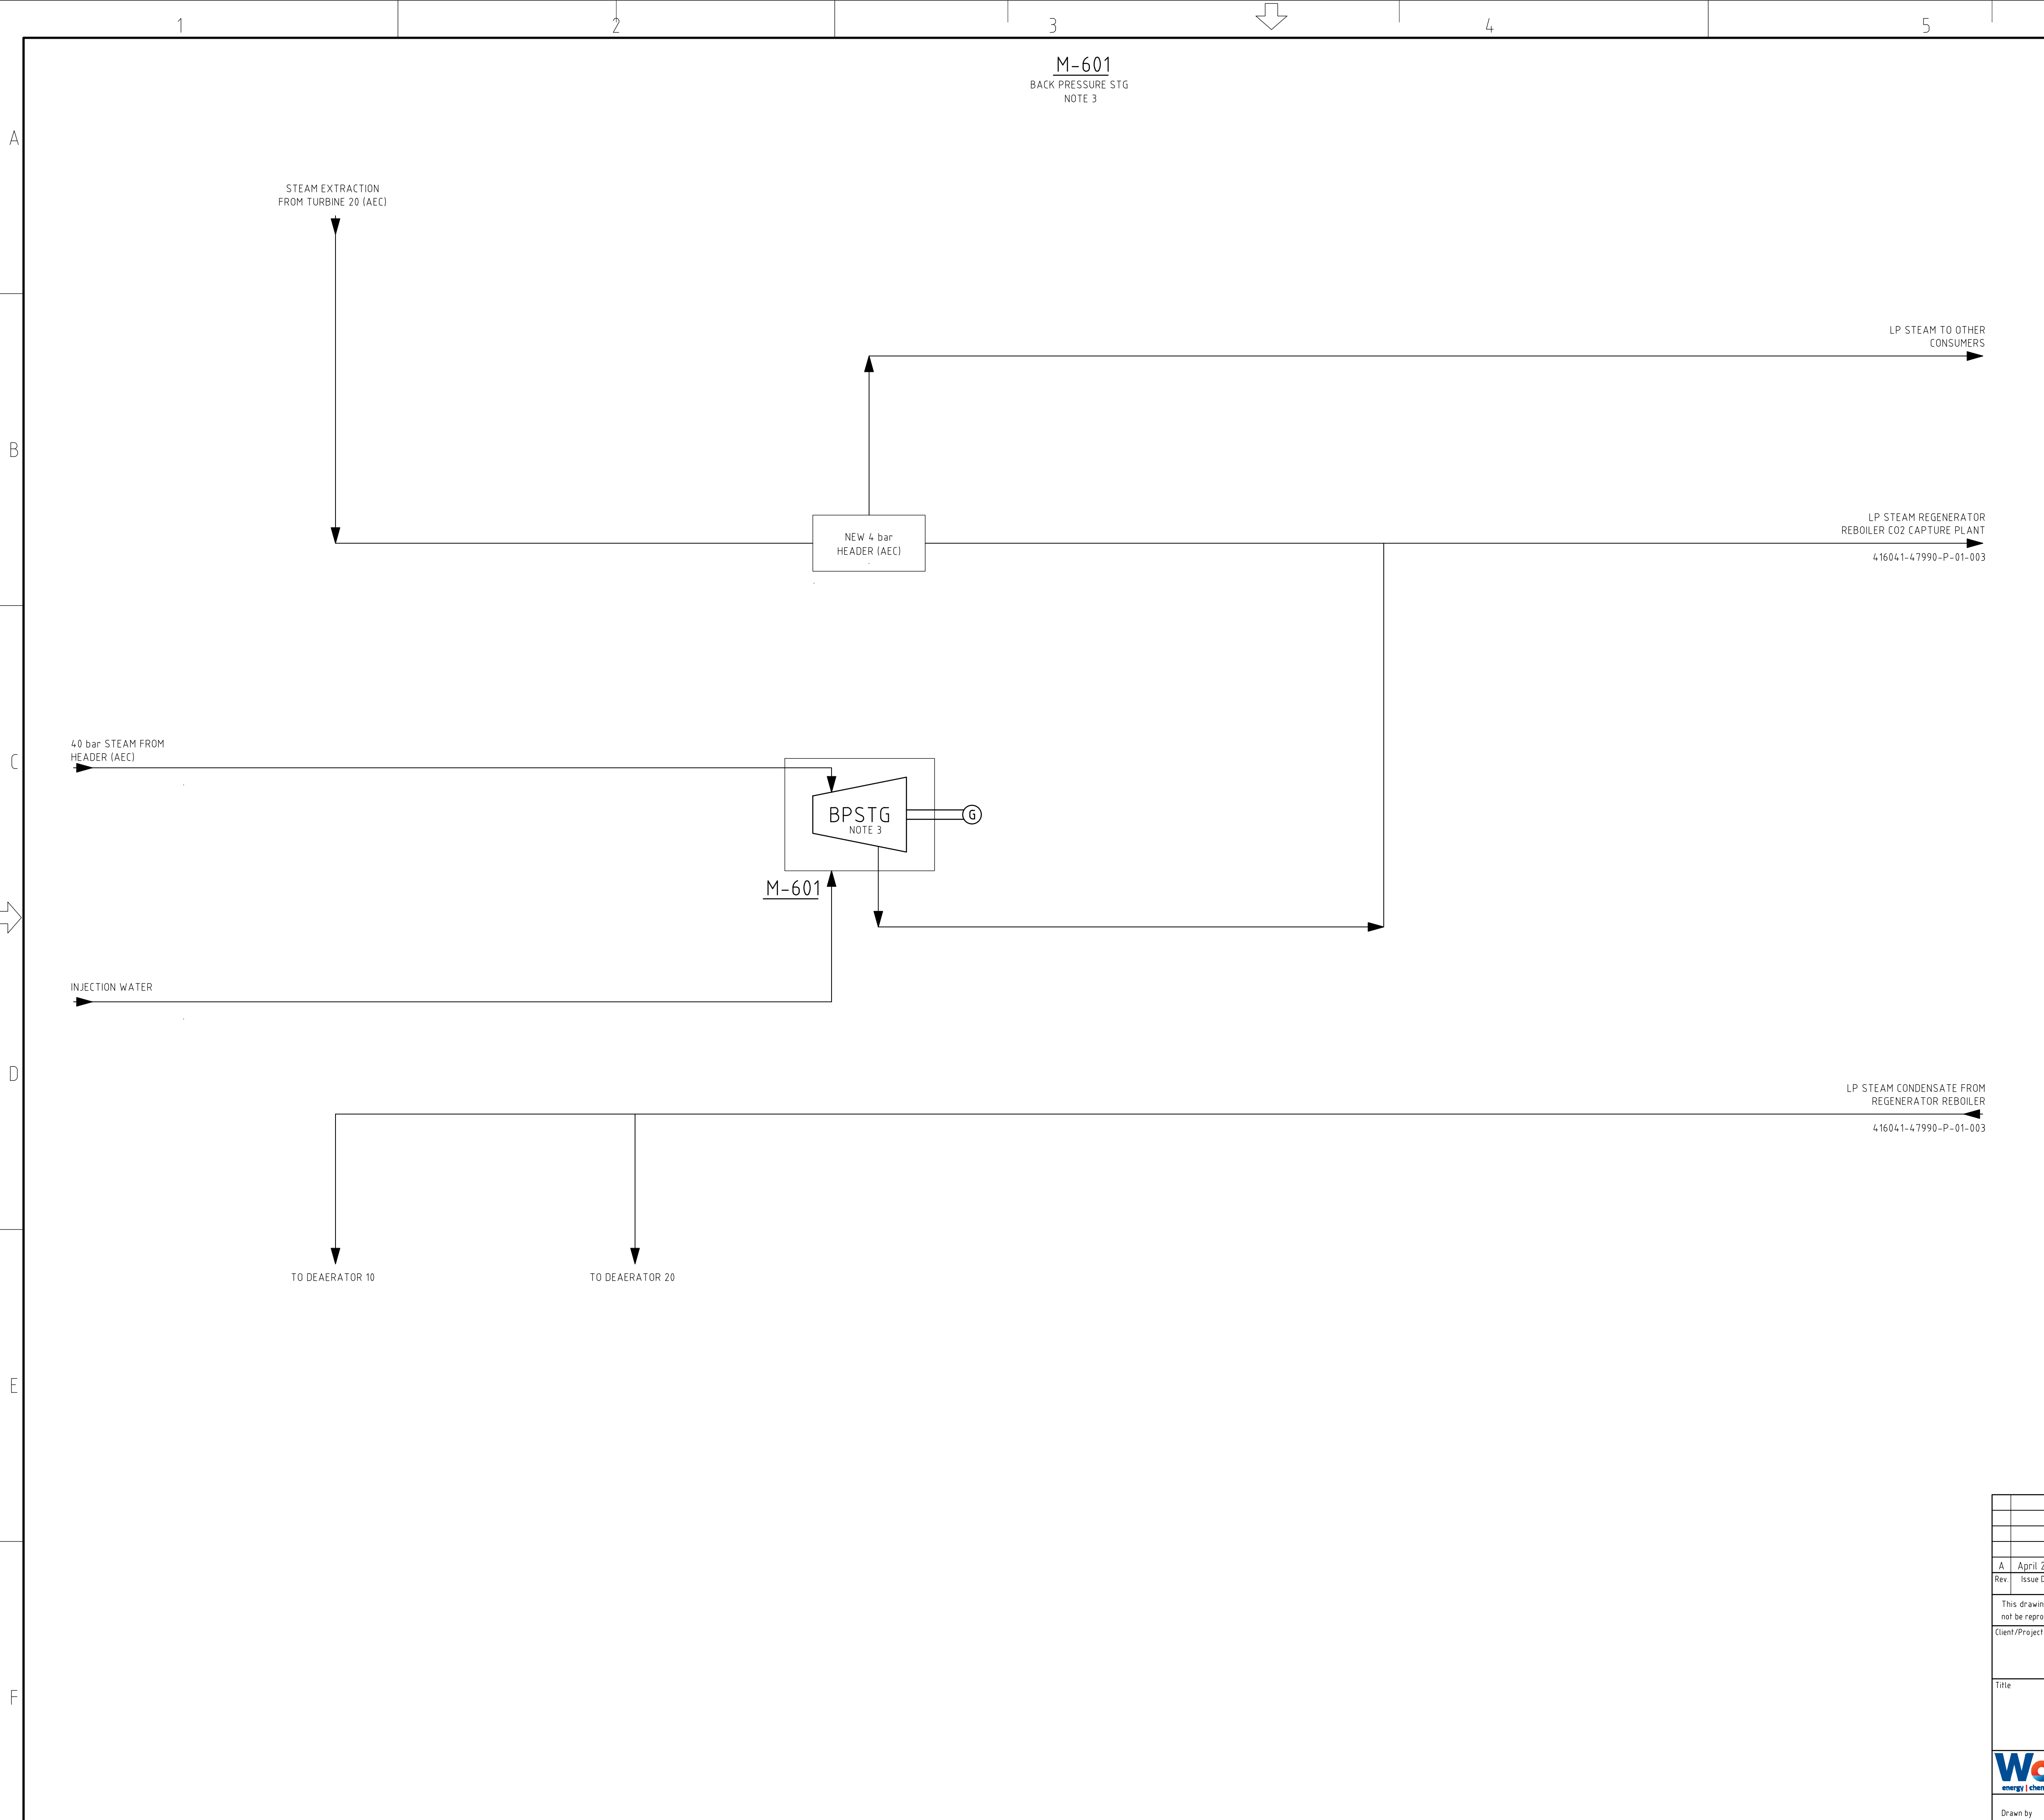

NOTES

1. SUFFICIENT STEAMTRAPS & DRAIN FACILITIES TO BE PROVIDED MAINLY FOR START-UP / SHUT-DOWN.
2. CONDENSATE TO BE DISCHARGED TO FUNNELS,
3. BACK-PRESSURE STG INCLUDING DESUPERHEATER.

ABBREVIATIONS

AEC = AFVAL ENERGIE CENTRALE
BPSTG = BACK PRESSURE STEAM TURBINE GENERATOR
ESD = EMERGENCY SHUT DOWN
LP = LOW PRESSURE

	A	April 2023	For Client Review	SAR Prepared by	B.L.G.J. Checked by	THAX Disc Appr by	JOC Proj Appr by
Revision Description							
This drawing is the property of Worley and/or Client and it is loaned with the restriction that the borrower undertakes that it shall not be reproduced, copied, loaned or otherwise disposed of (directly or indirectly) nor used for any purpose other than for which it is specifically provided.							
Client/Project Name							
AEB AMSTERDAM, NL							
Title	PROCESS FLOW DIAGRAM						
LP STEAM SUPPLY & CONDENSATE RETURN							
				Drawing Number	41604-1-47990-P-01-014		
Drawn by	SAR	Date	April 2023	Drawing Scale	NTS	Drawing Size	A1
Sheet 1				of 1		Issue A	